


SITE ENGINEER:


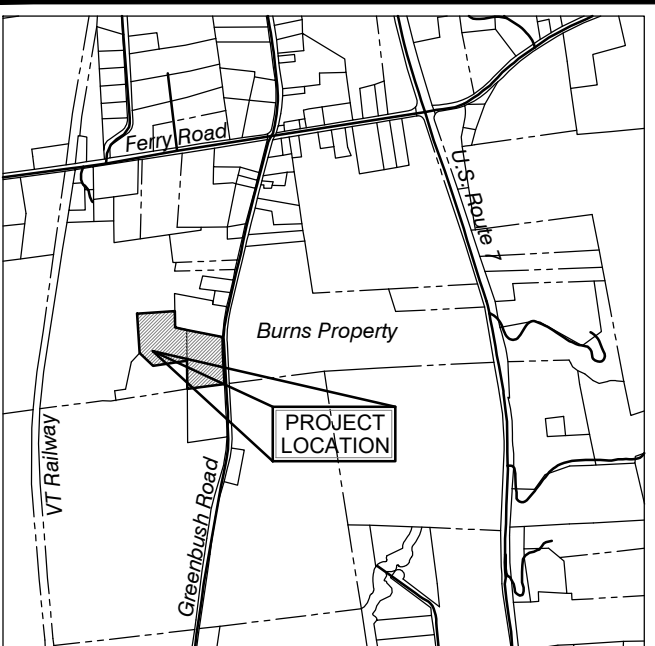
CIVIL ENGINEERING ASSOCIATES, INC.
 10 MANSFIELD VIEW LANE, SOUTH BURLINGTON, VT 05403
 P: 802-864-2923 FAX: 802-864-2271 web: www.cea-vt.com

COPYRIGHT © 2024 - ALL RIGHTS RESERVED

DRAWN
SAL
 CHECKED
DSM
 APPROVED
DSM

CLIENT:
R. & L. GAUJAC
 GREENBUSH ROAD
 CHARLOTTE
 VERMONT

PROJECT:
**OLD LANTERN
 BARN & OLD
 LANTERN INN**
 GREENBUSH ROAD
 CHARLOTTE, VT



LOCATION MAP
 1" = 2000'

DATE	CHECKED	REVISION
6/5/23	DSM	MISC. REVISIONS
7/7/23	DSM	MISC. REVISIONS
7/17/23	DSM	REV. LV 1.0 REPLACEMENT AREAS
7/18/23	DSM	REVISED EASEMENT NOTE
9/06/23	DSM	REVISED REPLACEMENT AREAS
11/13/23	DSM	REV. FIRE & WATER SUPPLY LINES
10/14/24	DSM	REVISED EASEMENT NOTE
10/15/24	DSM	REV. FLEA MARKET WM LOCATION
10/25/24	DSM	REVISED PER ATTORNEY REVIEW

SITE PLAN

DATE
NOV, 2022
 SCALE
1" = 50'
 PROJ. NO.
09223

DRAWING NUMBER
C1.0

**THIS PROPERTY IS LOCATED WITHIN THE
 WEST CHARLOTTE VILLAGE ZONING DISTRICT**

